

Rosefield Solar Farm

Environmental Statement

Volume 3
Chapter 5: Approach to the EIA


APFP Regulation Reg 5(2)(a)
Planning Act 2008
Infrastructure Planning
(Applications: Prescribed Forms
and Procedure) Regulations 2009
EN010158/APP/6.3
September 2025
Rosefield Energyfarm Limited



ES Volume 3: Figures

Chapter 5: Approach to the EIA

Drawing number	Revision number	Drawing title	Scale
5.1	01	Desk-Based Study of Existing Utilities	1:10,000 @ A3

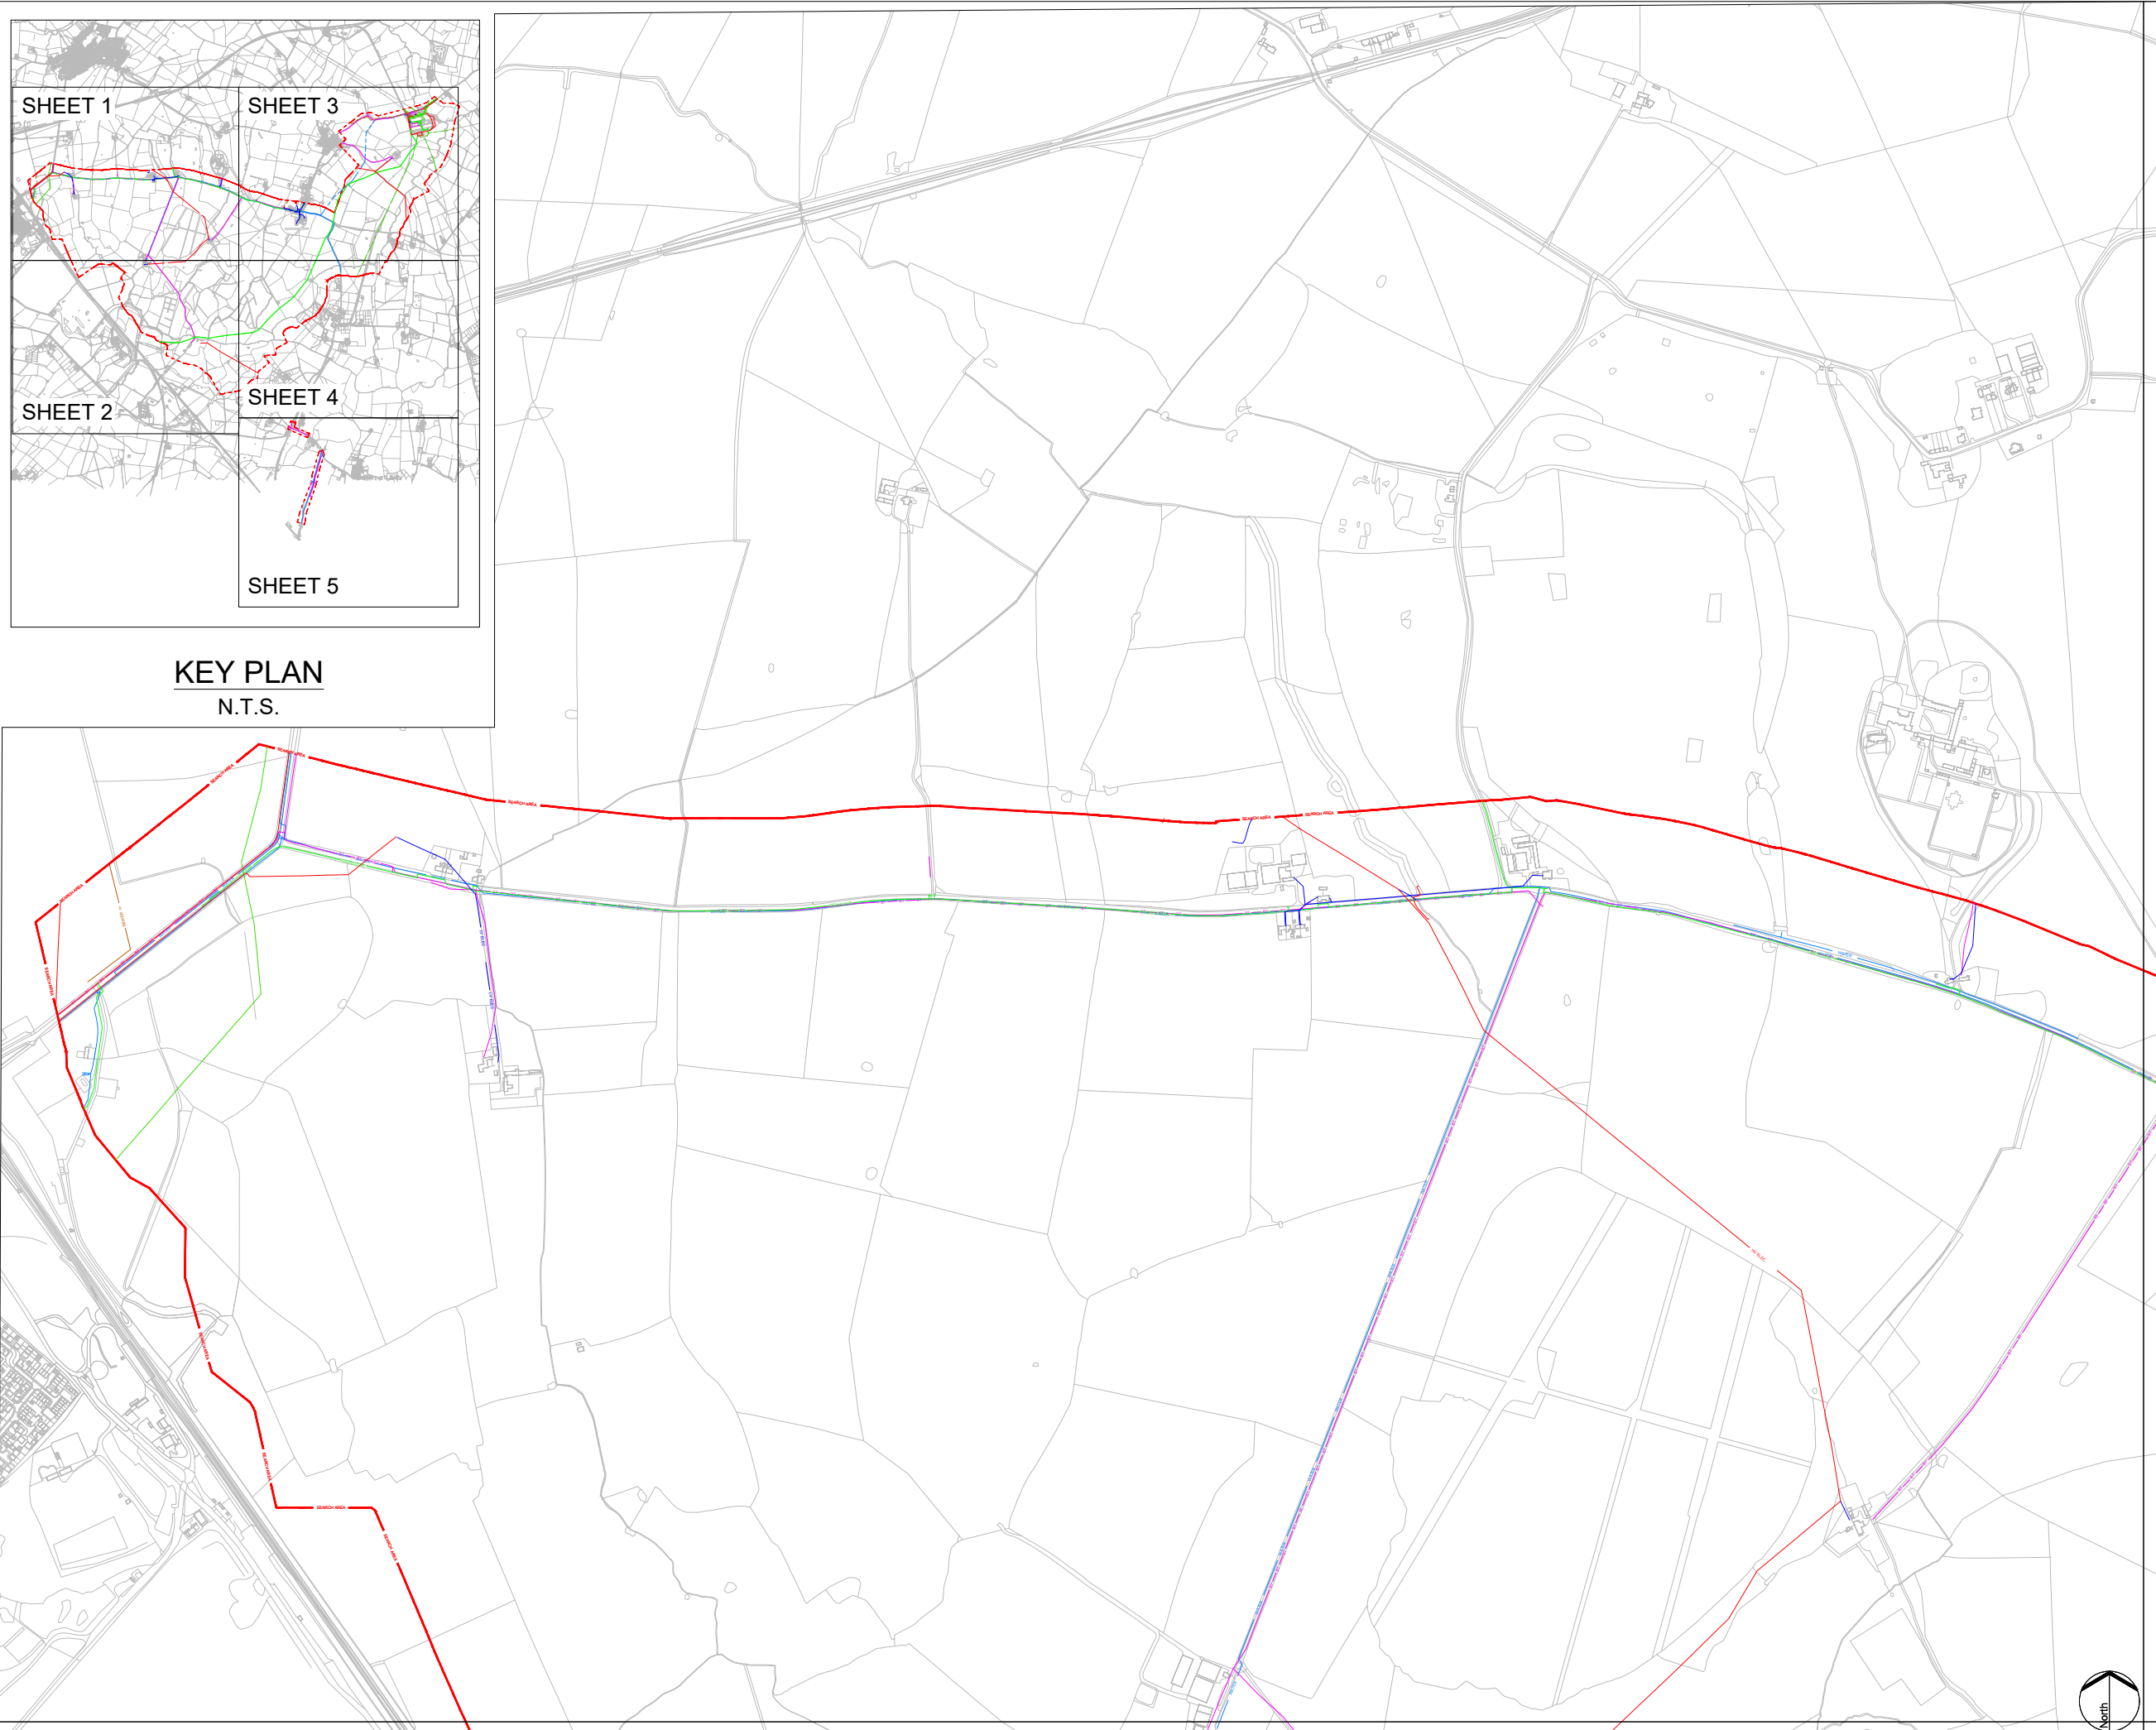

KEY:

ARELION

BT

COLT

CITY FIBRE

CSP FIBRE

LV ELEC

HV ELEC

EHV ELEC

ES PIPELINES

EU NETWORKS

EXA

FULCRUM

GAMMA

GAS - LP

GAS - MP

GAS - IP

GAS - HP

GTC ELECTRIC

GTC GAS

GTT

ARELION

BT

COLT

CITY FIBRE

CSP FIBRE

LV ELEC

HV ELEC

EHV ELEC

ES PIPELINES

EU NETWORKS

EXA

FULCRUM

GAMMA

GAS - LP

GAS - MP

GAS - IP

GAS - HP

GTC ELECTRIC

GTC GAS

GTT

LAST MILE

OCU LUMEN

SEARCH AREA

SEWER FW

SEWER SW

SEWER COM

SKY

TATA

TFL

VERIZON

VIRGIN

VODAFONE

WATER

ZAYO

GIGACLEAR

G NETWORK

KCOM

KPN

LAST MILE

LU POWERLINK

NG FIBRE

SEARCH AREA

SEWER FW

SEWER SW

SEWER COM

SKY

TATA

TFL

VERIZON

VIRGIN

VODAFONE

WATER

ZAYO

GIGACLEAR

LINES MAY INDICATE MULTIPLE CABLES

NOTES:

THIS DRAWING IS A REPRESENTATIVE "FUSION PLAN" COMPILED FROM PLANS PROVIDED BY ASSET OWNING ORGANISATIONS WHOSE PLANT OR ASSETS COULD BE AFFECTED BY WORKS UNDERTAKEN ON THE SITE DETAILED HEREIN.

DO NOT SCALE FROM THIS DRAWING

THE INFORMATION PROVIDED ON THIS MAPPING PLAN IS BASED ON HISTORIC RECORDS PROVIDED BY THE STATUTORY UNDERTAKERS. THE ACTUAL POSITION AND STATUS OF ANY MAINS AND SERVICES MUST BE VERIFIED ON SITE. THIS PLAN IS FOR INFORMATION PURPOSES ONLY.

THE INFORMATION ON THIS PLAN IS GIVEN WITHOUT OBLIGATION OR WARRANTY. NO LIABILITY OF ANY KIND WHATSOEVER IS ACCEPTED BY CENTARA LTD, OUR AGENTS OR PARTNERS FOR ANY ERRORS OR OMISSIONS.

SERVICES TO BUILDINGS ARE NOT ALWAYS SHOWN BUT IT MUST BE ASSUMED THAT ANY EXISTING BUILDING IS SERVED WITH "LIVE" SUPPLIES UNTIL PROVEN OTHERWISE. YOU MUST OBTAIN WRITTEN CONFIRMATION FROM THE RELEVANT UTILITY THAT A SUPPLY IS "DEAD".

CABLES TO STREET LIGHTING, ROAD SIGNS AND ILLUMINATED BOLLARDS ARE NOT ALWAYS SHOWN BUT MUST BE ASSUMED TO EXIST.

THE LOCATION OF ANY MAINS AND SERVICES MUST BE LOCATED USING EML OR GPR SURVEYS FOLLOWED, IF REQUIRED BY HAND DUG TRIAL HOLES. BEFORE USING ANY MECHANICAL PLANT YOU MUST OBTAIN APPROVAL FROM THE APPROPRIATE UTILITY.

UNDERGROUND SERVICES MUST BE LOCATED IN ACCORDANCE WITH HSE GUIDANCE NOTE HS (G) 47 AND BSI's PAS 128 2014.

01	Sept 25	DCO SUBMISSION	JR	CC	JH
Rev	Date	Description	Drn	Chk	App

Rosefield Solar Farm

Rosefield

Solar Farm

DOCUMENT:
ENVIRONMENTAL STATEMENT
VOLUME 3: FIGURES
REGULATION 5(2)(a)

TITLE:
FIGURE 5.1 - DESK - BASED STUDY OF EXISTING UTILITIES
SHEET 1 OF 5

PINS REFERENCE NUMBER:
EN010158/APP/6.3



SCALE : 1:10,000 @ A3
0m 200m 400m

REV:
01

© Copyright 2023 Rosefield Energy Farm Limited (11618221). No part of this drawing is to be reproduced without prior permission of Rosefield Energy Farm Limited.

This drawing may contain: Ordnance Survey material by permission of Ordnance Survey on behalf of the Controller of His Majesty's Stationery Office © Crown Copyright 2023. All rights reserved. Reference number 0100031673

OS Open data / © Natural England / © DEFRA / © DECC / © English Heritage. Aerial Photography - ESRI, DigitalGlobe, GEOEye, i-cubed, USDA FSA,USGD, AEX, Getmapping, Aerogrid, IGN,IGP,swisstopo, the GIS User Community

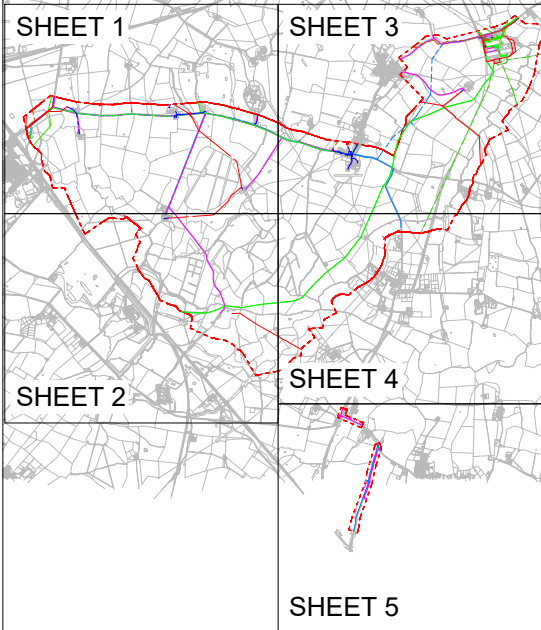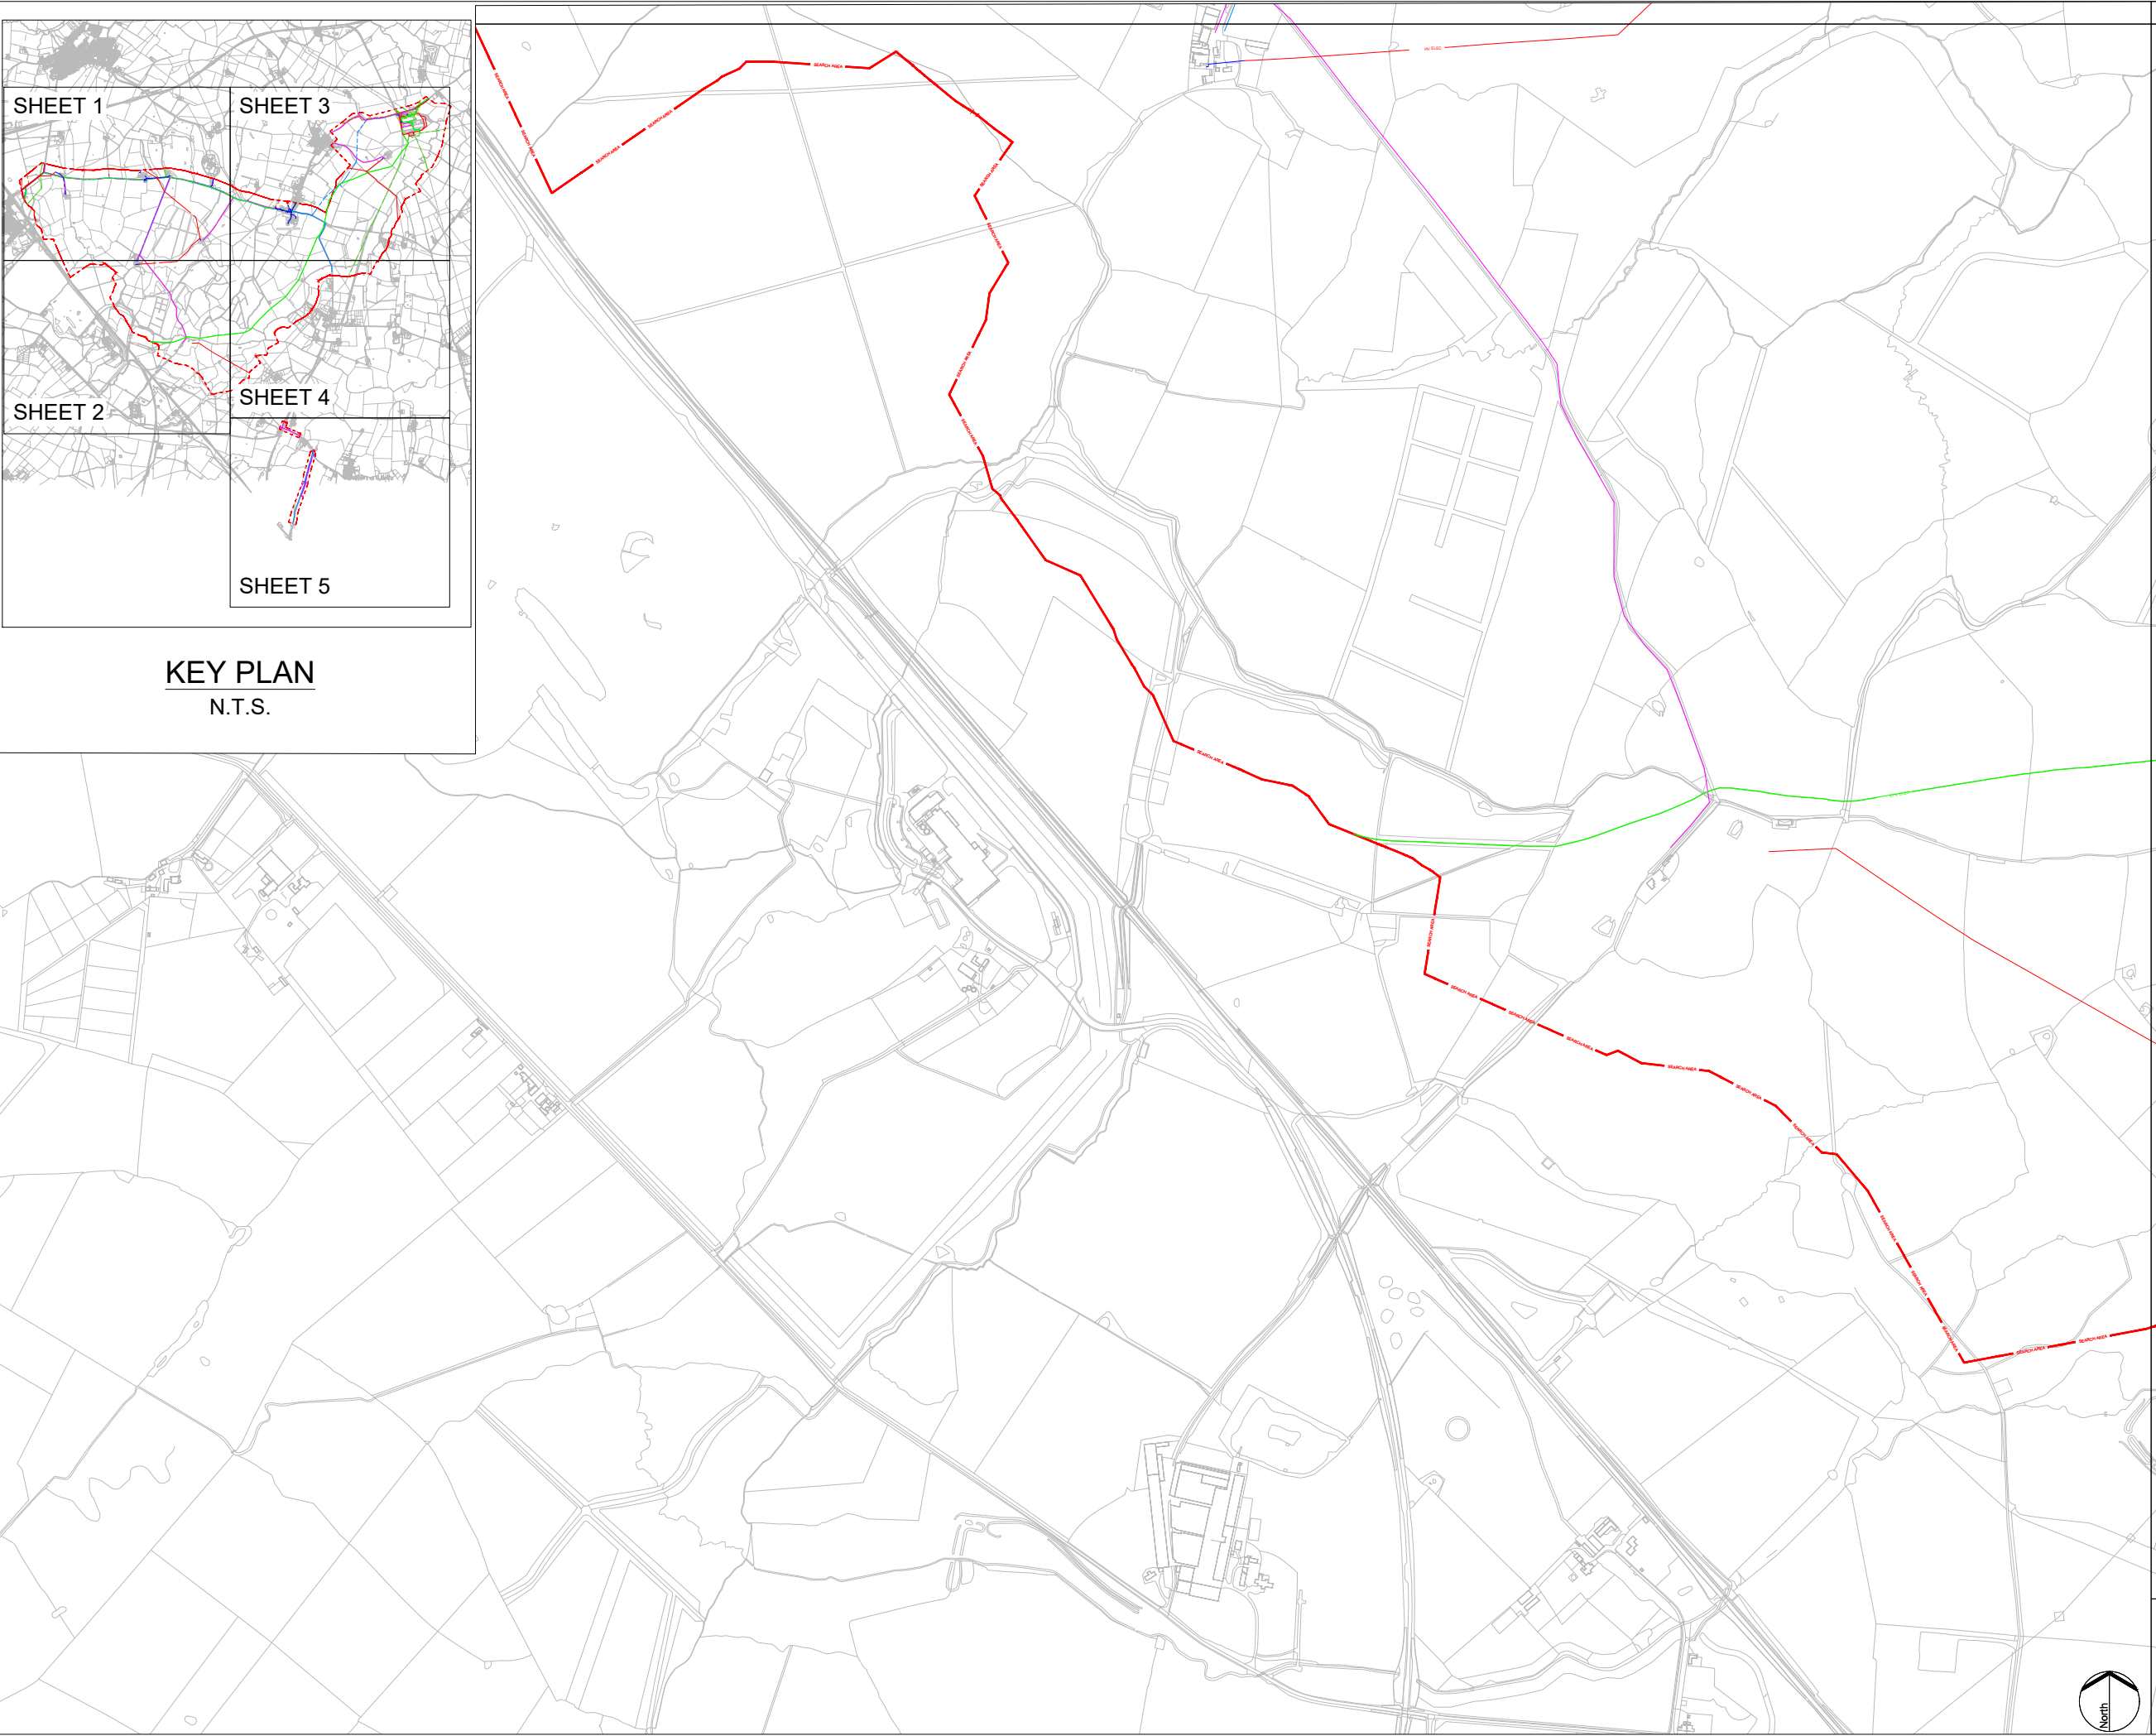

KEY PLAN
N.T.S.

KEY:			
	ARELION		G NETWORK
	BT		KCOM
	COLT		KPN
	CITY FIBRE		LAST MILE
	CSP FIBRE		LU POWERLINK
	LV ELEC		NG FIBRE
	HV ELEC		OCU LUMEN
	EHV ELEC		SEARCH AREA
	ES PIPELINES		SEWER FW
	EU NETWORKS		SEWER SW
	EXA		SEWER COM
	FULCRUM		SKY
	GAMMA		TATA
	GAS - LP		TFL
	GAS - MP		VERIZON
	GAS - IP		VIRGIN
	GAS - HP		VODAFONE
	GTC ELECTRIC		WATER
	GTC GAS		ZAYO
	GTT		GIGACLEAR

LINES MAY INDICATE MULTIPLE CABLES

- NOTES:
- THIS DRAWING IS A REPRESENTATIVE "FUSION PLAN" COMPILED FROM PLANS PROVIDED BY ASSET OWNING ORGANISATIONS WHOSE PLANT OR ASSETS COULD BE AFFECTED BY WORKS UNDERTAKEN ON THE SITE DETAILED HEREIN.
 - DO NOT SCALE FROM THIS DRAWING
 - THE INFORMATION PROVIDED ON THIS MAPPING PLAN IS BASED ON HISTORIC RECORDS PROVIDED BY THE STATUTORY UNDERTAKERS. THE ACTUAL POSITION AND STATUS OF ANY MAINS AND SERVICES MUST BE VERIFIED ON SITE. THIS PLAN IS FOR INFORMATION PURPOSES ONLY.
 - THE INFORMATION ON THIS PLAN IS GIVEN WITHOUT OBLIGATION OR WARRANTY. NO LIABILITY OF ANY KIND WHATSOEVER IS ACCEPTED BY CENTARA LTD, OUR AGENTS OR PARTNERS FOR ANY ERRORS OR OMISSIONS.
 - SERVICES TO BUILDINGS ARE NOT ALWAYS SHOWN BUT IT MUST BE ASSUMED THAT ANY EXISTING BUILDING IS SERVED WITH "LIVE" SUPPLIES UNTIL PROVEN OTHERWISE. YOU MUST OBTAIN WRITTEN CONFIRMATION FROM THE RELEVANT UTILITY THAT A SUPPLY IS "DEAD".
 - CABLES TO STREET LIGHTING, ROAD SIGNS AND ILLUMINATED BOLLARDS ARE NOT ALWAYS SHOWN BUT MUST BE ASSUMED TO EXIST.
 - THE LOCATION OF ANY MAINS AND SERVICES MUST BE LOCATED USING EML OR GPR SURVEYS FOLLOWED, IF REQUIRED BY HAND DUG TRIAL HOLES. BEFORE USING ANY MECHANICAL PLANT YOU MUST OBTAIN APPROVAL FROM THE APPROPRIATE UTILITY.
 - UNDERGROUND SERVICES MUST BE LOCATED IN ACCORDANCE WITH HSE GUIDANCE NOTE HS (G) 47 AND BSI's PAS 128 2014.

01	Sept 25	DCO SUBMISSION	JR	CC	JH
Rev	Date	Description	Drn	Chk	App

Rosefield Solar Farm


DOCUMENT:
ENVIRONMENTAL STATEMENT
VOLUME 3: FIGURES
REGULATION 5(2)(a)

TITLE:
FIGURE 5.1 - DESK - BASED STUDY OF EXISTING UTILITIES
SHEET 2 OF 5

PINS REFERENCE NUMBER:
EN010158/APP/6.3

SCALE : 1:10,000 @ A3

REV:
01

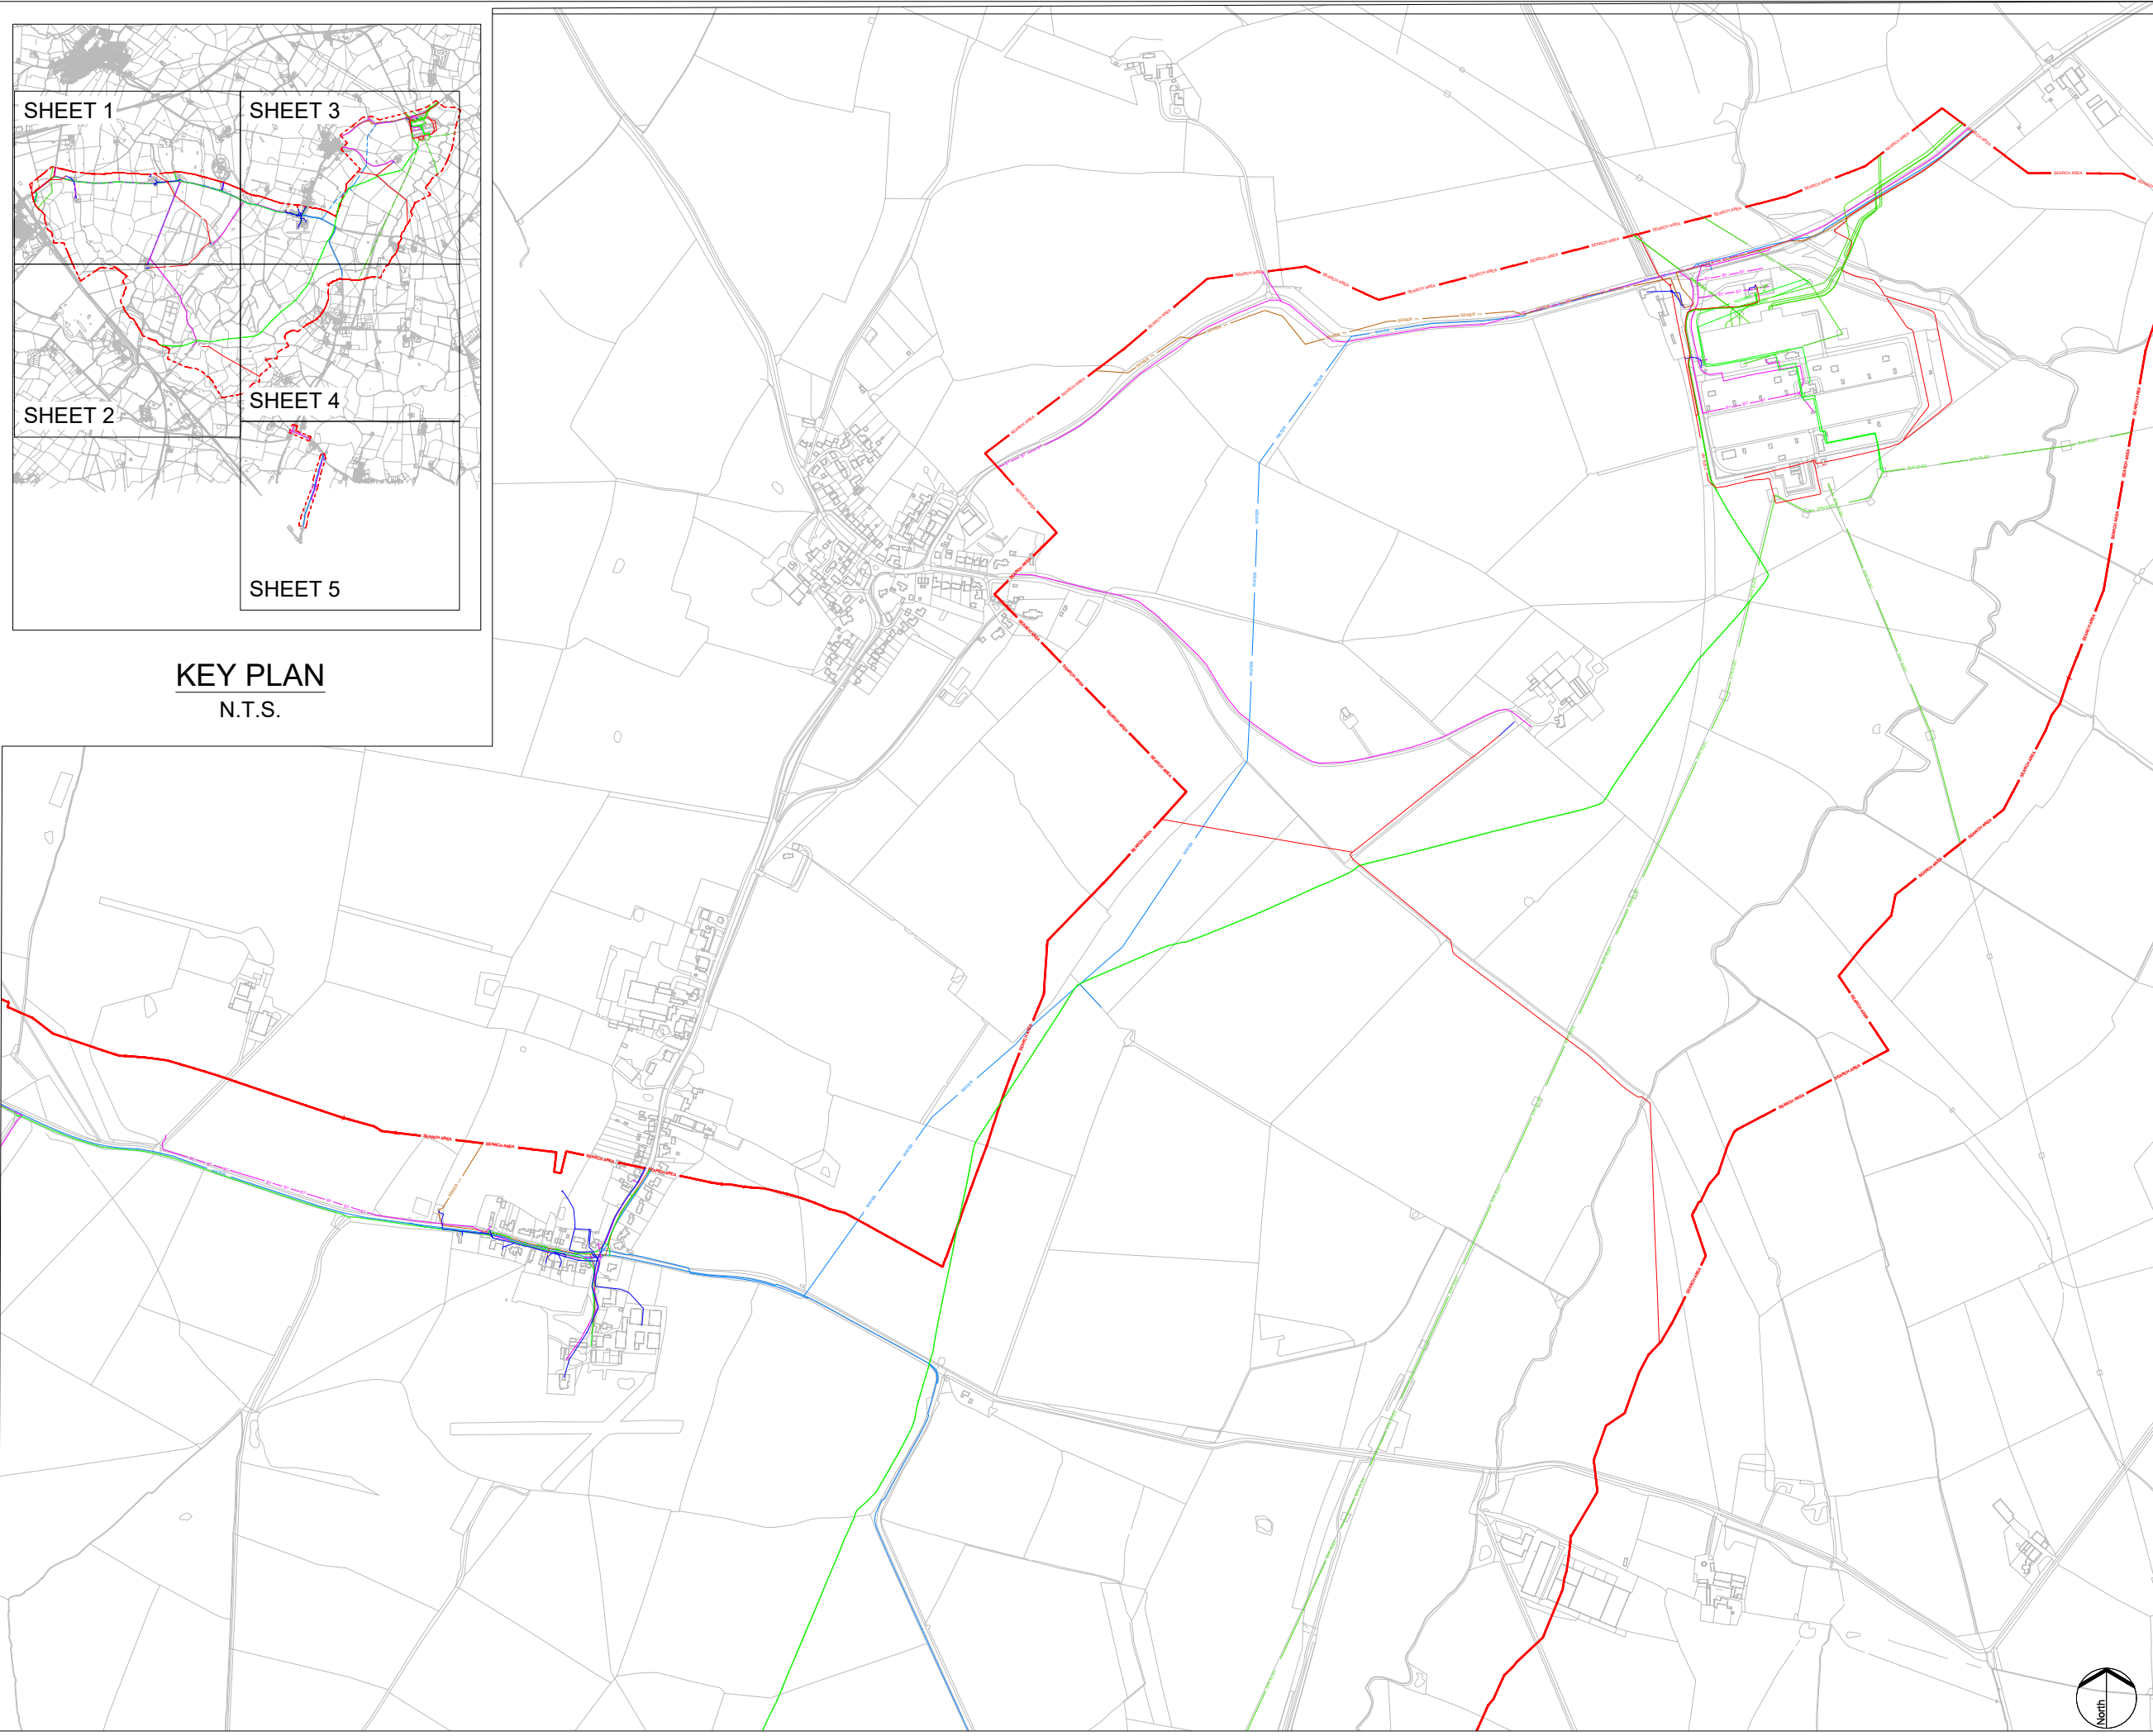

KEY:

	ARELION		G NETWORK
	BT		KCOM
	COLT		KPN
	CITY FIBRE		LAST MILE
	CSP FIBRE		LU POWERLINK
	LV ELEC		NG FIBRE
	HV ELEC		OCU LUMEN
	EHV ELEC		SEARCH AREA
	ES PIPELINES		SEWER FW
	EU NETWORKS		SEWER SW
	EXA		SEWER COM
	FULCRUM		SKY
	GAMMA		TATA
	GAS - LP		TFL
	GAS - MP		VERIZON
	GAS - IP		VIRGIN
	GAS - HP		VODAFONE
	GTC ELECTRIC		WATER
	GTC GAS		ZAYO
	GTT		GIGACLEAR

LINES MAY INDICATE MULTIPLE CABLES

- NOTES:
- THIS DRAWING IS A REPRESENTATIVE "FUSION PLAN" COMPILED FROM PLANS PROVIDED BY ASSET OWNING ORGANISATIONS WHOSE PLANT OR ASSETS COULD BE AFFECTED BY WORKS UNDERTAKEN ON THE SITE DETAILED HEREIN.
 - DO NOT SCALE FROM THIS DRAWING
 - THE INFORMATION PROVIDED ON THIS MAPPING PLAN IS BASED ON HISTORIC RECORDS PROVIDED BY THE STATUTORY UNDERTAKERS. THE ACTUAL POSITION AND STATUS OF ANY MAINS AND SERVICES MUST BE VERIFIED ON SITE. THIS PLAN IS FOR INFORMATION PURPOSES ONLY.
 - THE INFORMATION ON THIS PLAN IS GIVEN WITHOUT OBLIGATION OR WARRANTY. NO LIABILITY OF ANY KIND WHATSOEVER IS ACCEPTED BY CENTARA LTD, OUR AGENTS OR PARTNERS FOR ANY ERRORS OR OMISSIONS.
 - SERVICES TO BUILDINGS ARE NOT ALWAYS SHOWN BUT IT MUST BE ASSUMED THAT ANY EXISTING BUILDING IS SERVED WITH "LIVE" SUPPLIES UNTIL PROVEN OTHERWISE. YOU MUST OBTAIN WRITTEN CONFIRMATION FROM THE RELEVANT UTILITY THAT A SUPPLY IS "DEAD".
 - CABLES TO STREET LIGHTING, ROAD SIGNS AND ILLUMINATED BOLLARDS ARE NOT ALWAYS SHOWN BUT MUST BE ASSUMED TO EXIST.
 - THE LOCATION OF ANY MAINS AND SERVICES MUST BE LOCATED USING EML OR GPR SURVEYS FOLLOWED, IF REQUIRED BY HAND DUG TRIAL HOLES. BEFORE USING ANY MECHANICAL PLANT YOU MUST OBTAIN APPROVAL FROM THE APPROPRIATE UTILITY.
 - UNDERGROUND SERVICES MUST BE LOCATED IN ACCORDANCE WITH HSE GUIDANCE NOTE HS (G) 47 AND BSI's PAS 128 2014.

01	Sept 25	DCO SUBMISSION	JR	CC	JH
Rev	Date	Description	Drn	Chk	App

Rosefield Solar Farm


DOCUMENT:
ENVIRONMENTAL STATEMENT
VOLUME 3: FIGURES
REGULATION 5(2)(a)

TITLE:
FIGURE 5.1 - DESK - BASED STUDY OF EXISTING UTILITIES
SHEET 3 OF 5

PINS REFERENCE NUMBER:
EN010158/APP/6.3

SCALE : 1:10,000 @ A3
0m 200m 400m

REV:
01

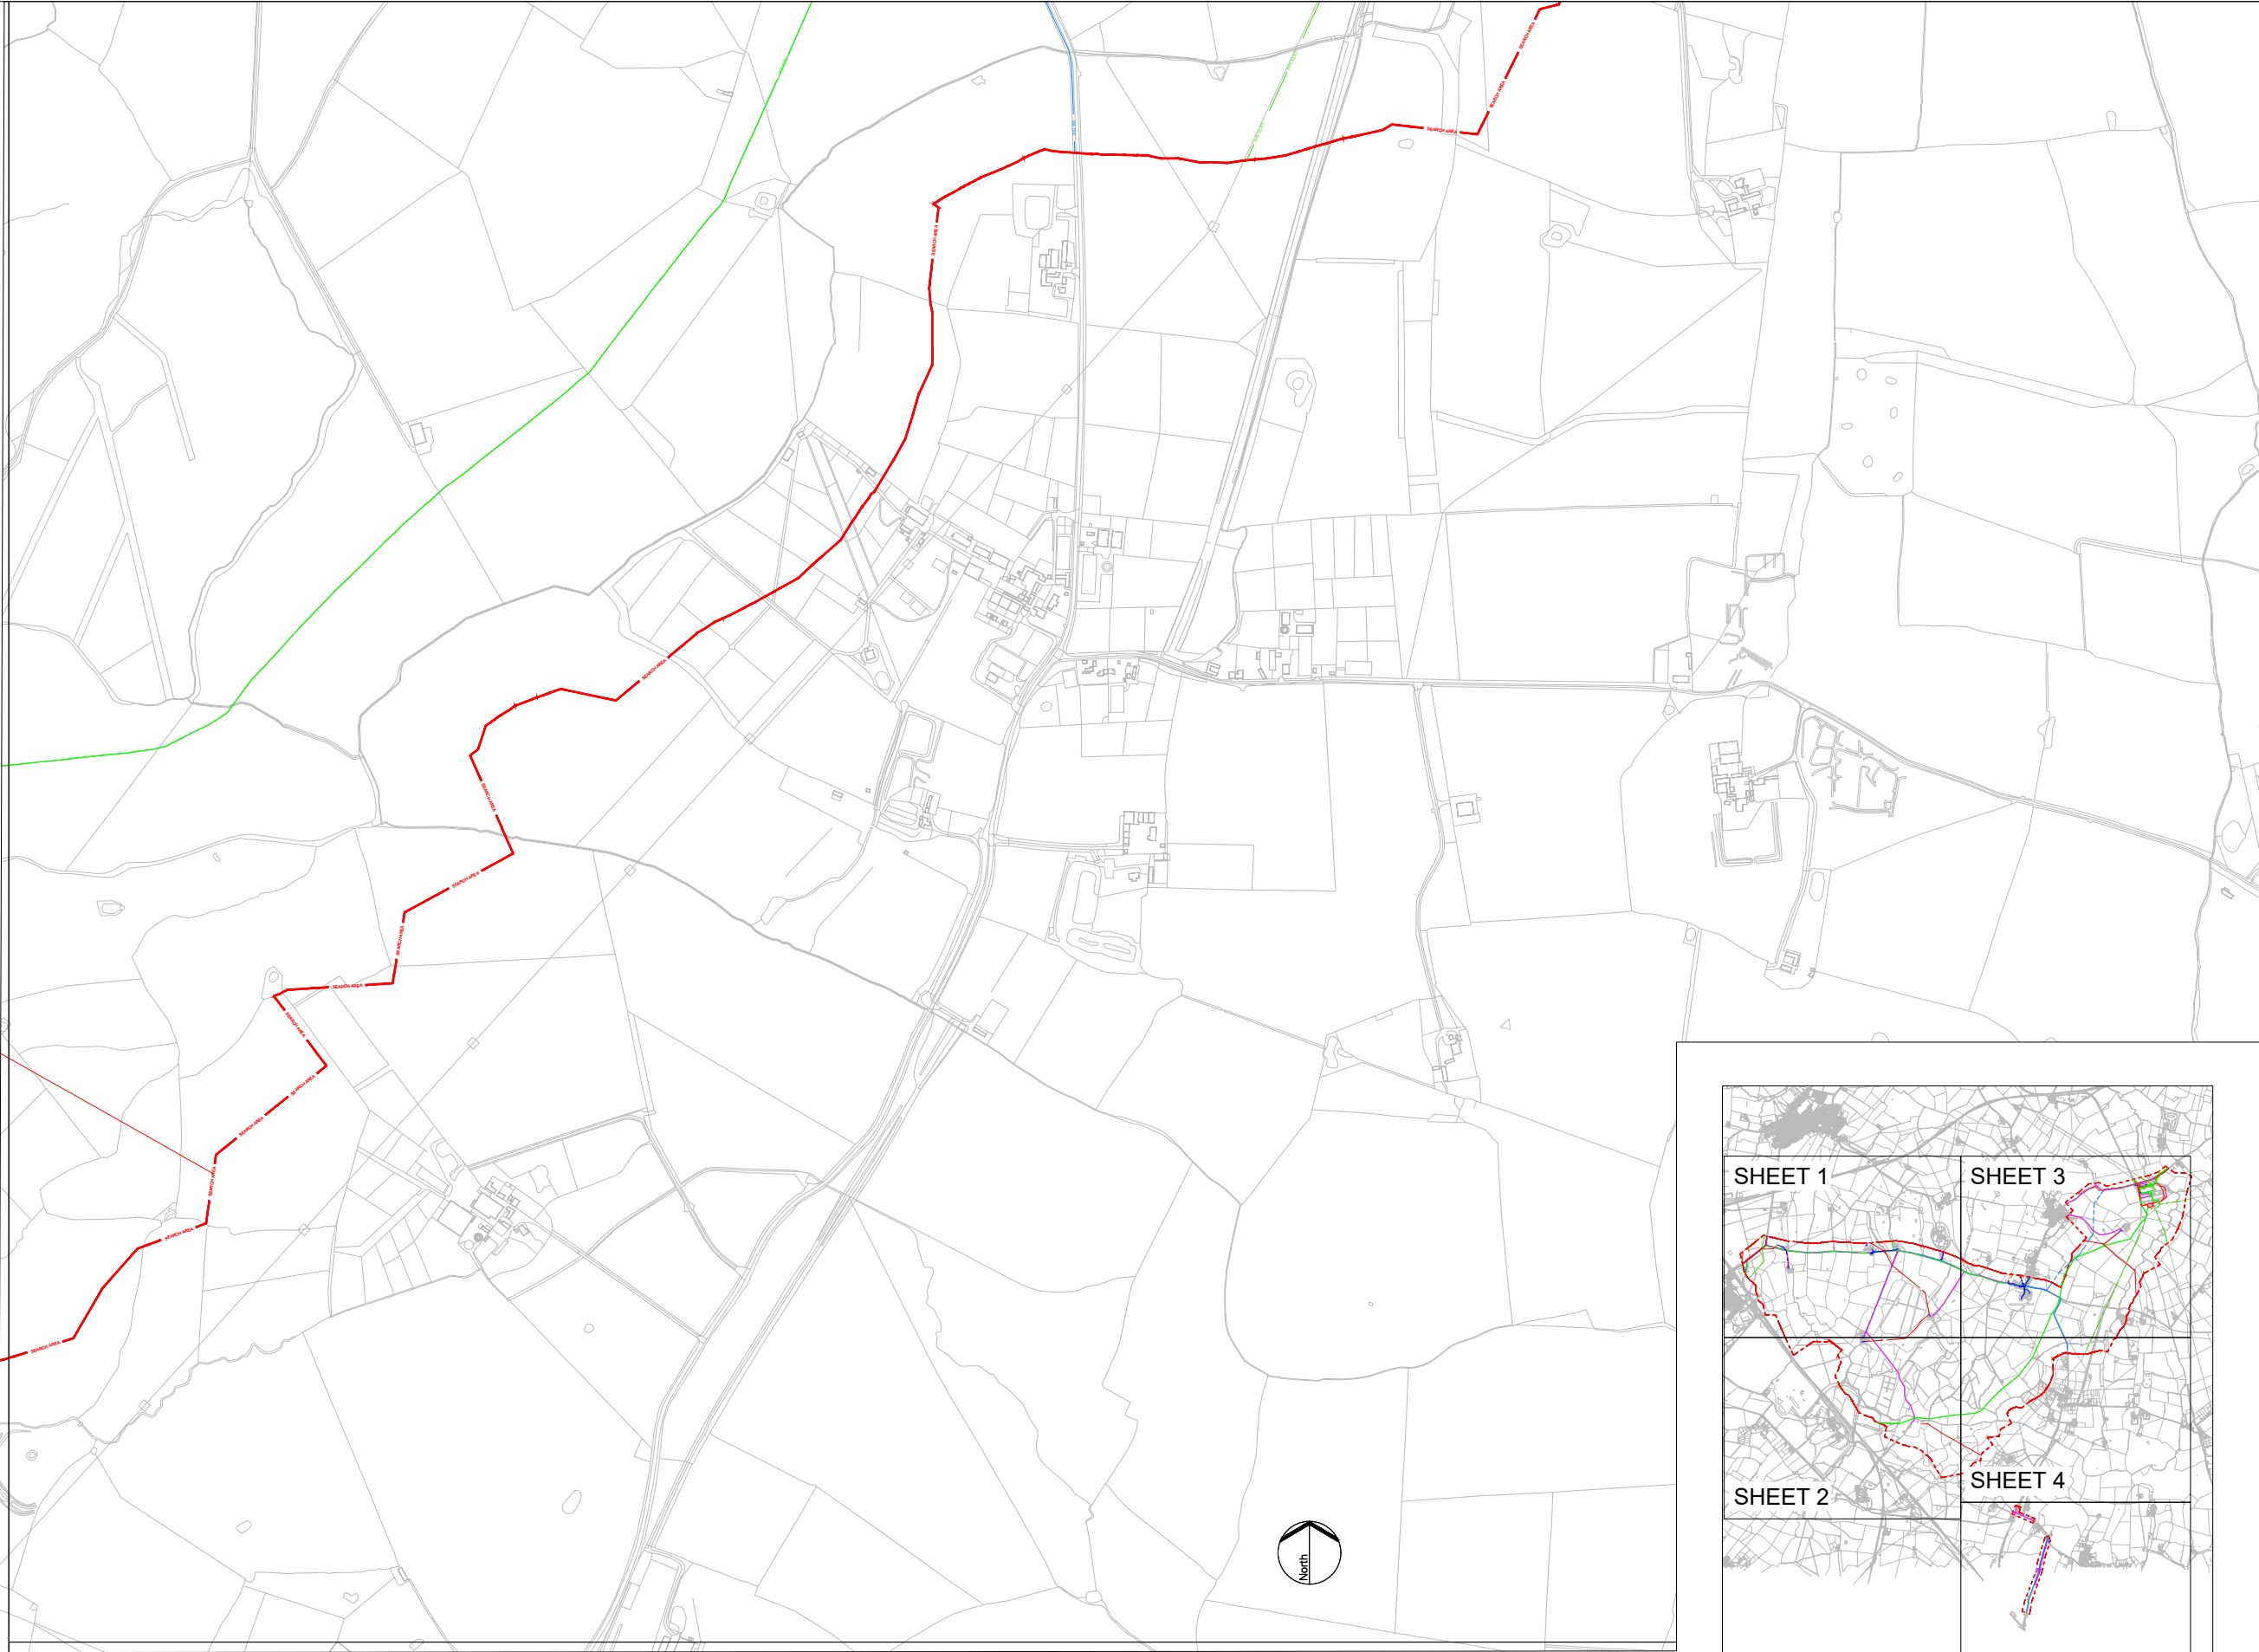

KEY:

	ARELION		G NETWORK
	BT		KCOM
	COLT		KPN
	CITY FIBRE		LAST MILE
	CSP FIBRE		LU POWERLINK
	LV ELEC		NG FIBRE
	HV ELEC		OCU LUMEN
	EHV ELEC		SEARCH AREA
	ES PIPELINES		SEWER FW
	EU NETWORKS		SEWER SW
	EXA		SEWER COM
	FULCRUM		SKY
	GAMMA		TATA
	GAS - LP		TFL
	GAS - MP		VERIZON
	GAS - IP		VIRGIN
	GAS - HP		VODAFONE
	GTC ELECTRIC		WATER
	GTC GAS		ZAYO
	GTT		GIGACLEAR

LINES MAY INDICATE MULTIPLE CABLES

NOTES:

- THIS DRAWING IS A REPRESENTATIVE "FUSION PLAN" COMPILED FROM PLANS PROVIDED BY ASSET OWNING ORGANISATIONS WHOSE PLANT OR ASSETS COULD BE AFFECTED BY WORKS UNDERTAKEN ON THE SITE DETAILED HEREIN.
- DO NOT SCALE FROM THIS DRAWING
- THE INFORMATION PROVIDED ON THIS MAPPING PLAN IS BASED ON HISTORIC RECORDS PROVIDED BY THE STATUTORY UNDERTAKERS. THE ACTUAL POSITION AND STATUS OF ANY MAINS AND SERVICES MUST BE VERIFIED ON SITE. THIS PLAN IS FOR INFORMATION PURPOSES ONLY.
- THE INFORMATION ON THIS PLAN IS GIVEN WITHOUT OBLIGATION OR WARRANTY. NO LIABILITY OF ANY KIND WHATSOEVER IS ACCEPTED BY CENTARA LTD, OUR AGENTS OR PARTNERS FOR ANY ERRORS OR OMISSIONS.
- SERVICES TO BUILDINGS ARE NOT ALWAYS SHOWN BUT IT MUST BE ASSUMED THAT ANY EXISTING BUILDING IS SERVED WITH "LIVE" SUPPLIES UNTIL PROVEN OTHERWISE. YOU MUST OBTAIN WRITTEN CONFIRMATION FROM THE RELEVANT UTILITY THAT A SUPPLY IS "DEAD".
- CABLES TO STREET LIGHTING, ROAD SIGNS AND ILLUMINATED BOLLARDS ARE NOT ALWAYS SHOWN BUT MUST BE ASSUMED TO EXIST.
- THE LOCATION OF ANY MAINS AND SERVICES MUST BE LOCATED USING EML OR GPR SURVEYS FOLLOWED, IF REQUIRED BY HAND DUG TRIAL HOLES. BEFORE USING ANY MECHANICAL PLANT YOU MUST OBTAIN APPROVAL FROM THE APPROPRIATE UTILITY.
- UNDERGROUND SERVICES MUST BE LOCATED IN ACCORDANCE WITH HSE GUIDANCE NOTE HS (G) 47 AND BSI's PAS 128 2014.

01	Sept 25	DCO SUBMISSION	JR	CC	JH
Rev	Date	Description	Drn	Chk	App

Rosefield Solar Farm




DOCUMENT:
ENVIRONMENTAL STATEMENT
VOLUME 3: FIGURES
REGULATION 5(2)(a)


TITLE:
FIGURE 5.1 - DESK - BASED STUDY OF EXISTING UTILITIES
SHEET 4 OF 5

PINS REFERENCE NUMBER:
EN010158/APP/6.3

SCALE : 1:10,000 @ A3	REV: 01

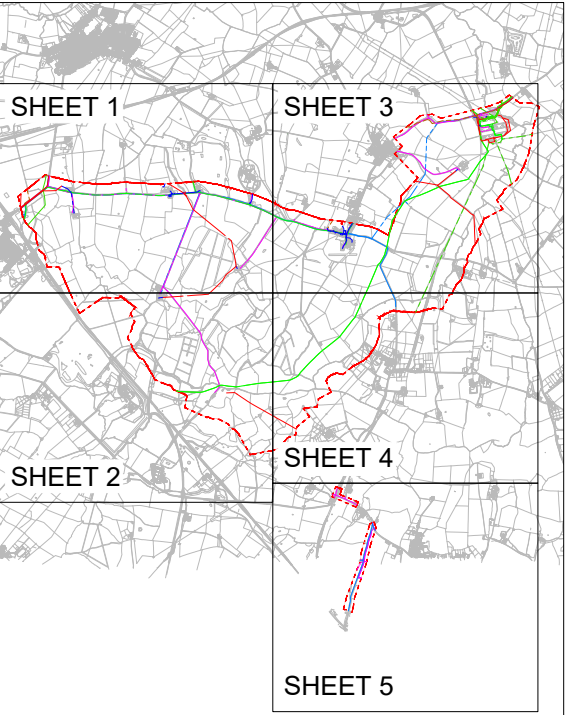

KEY PLAN
N.T.S.

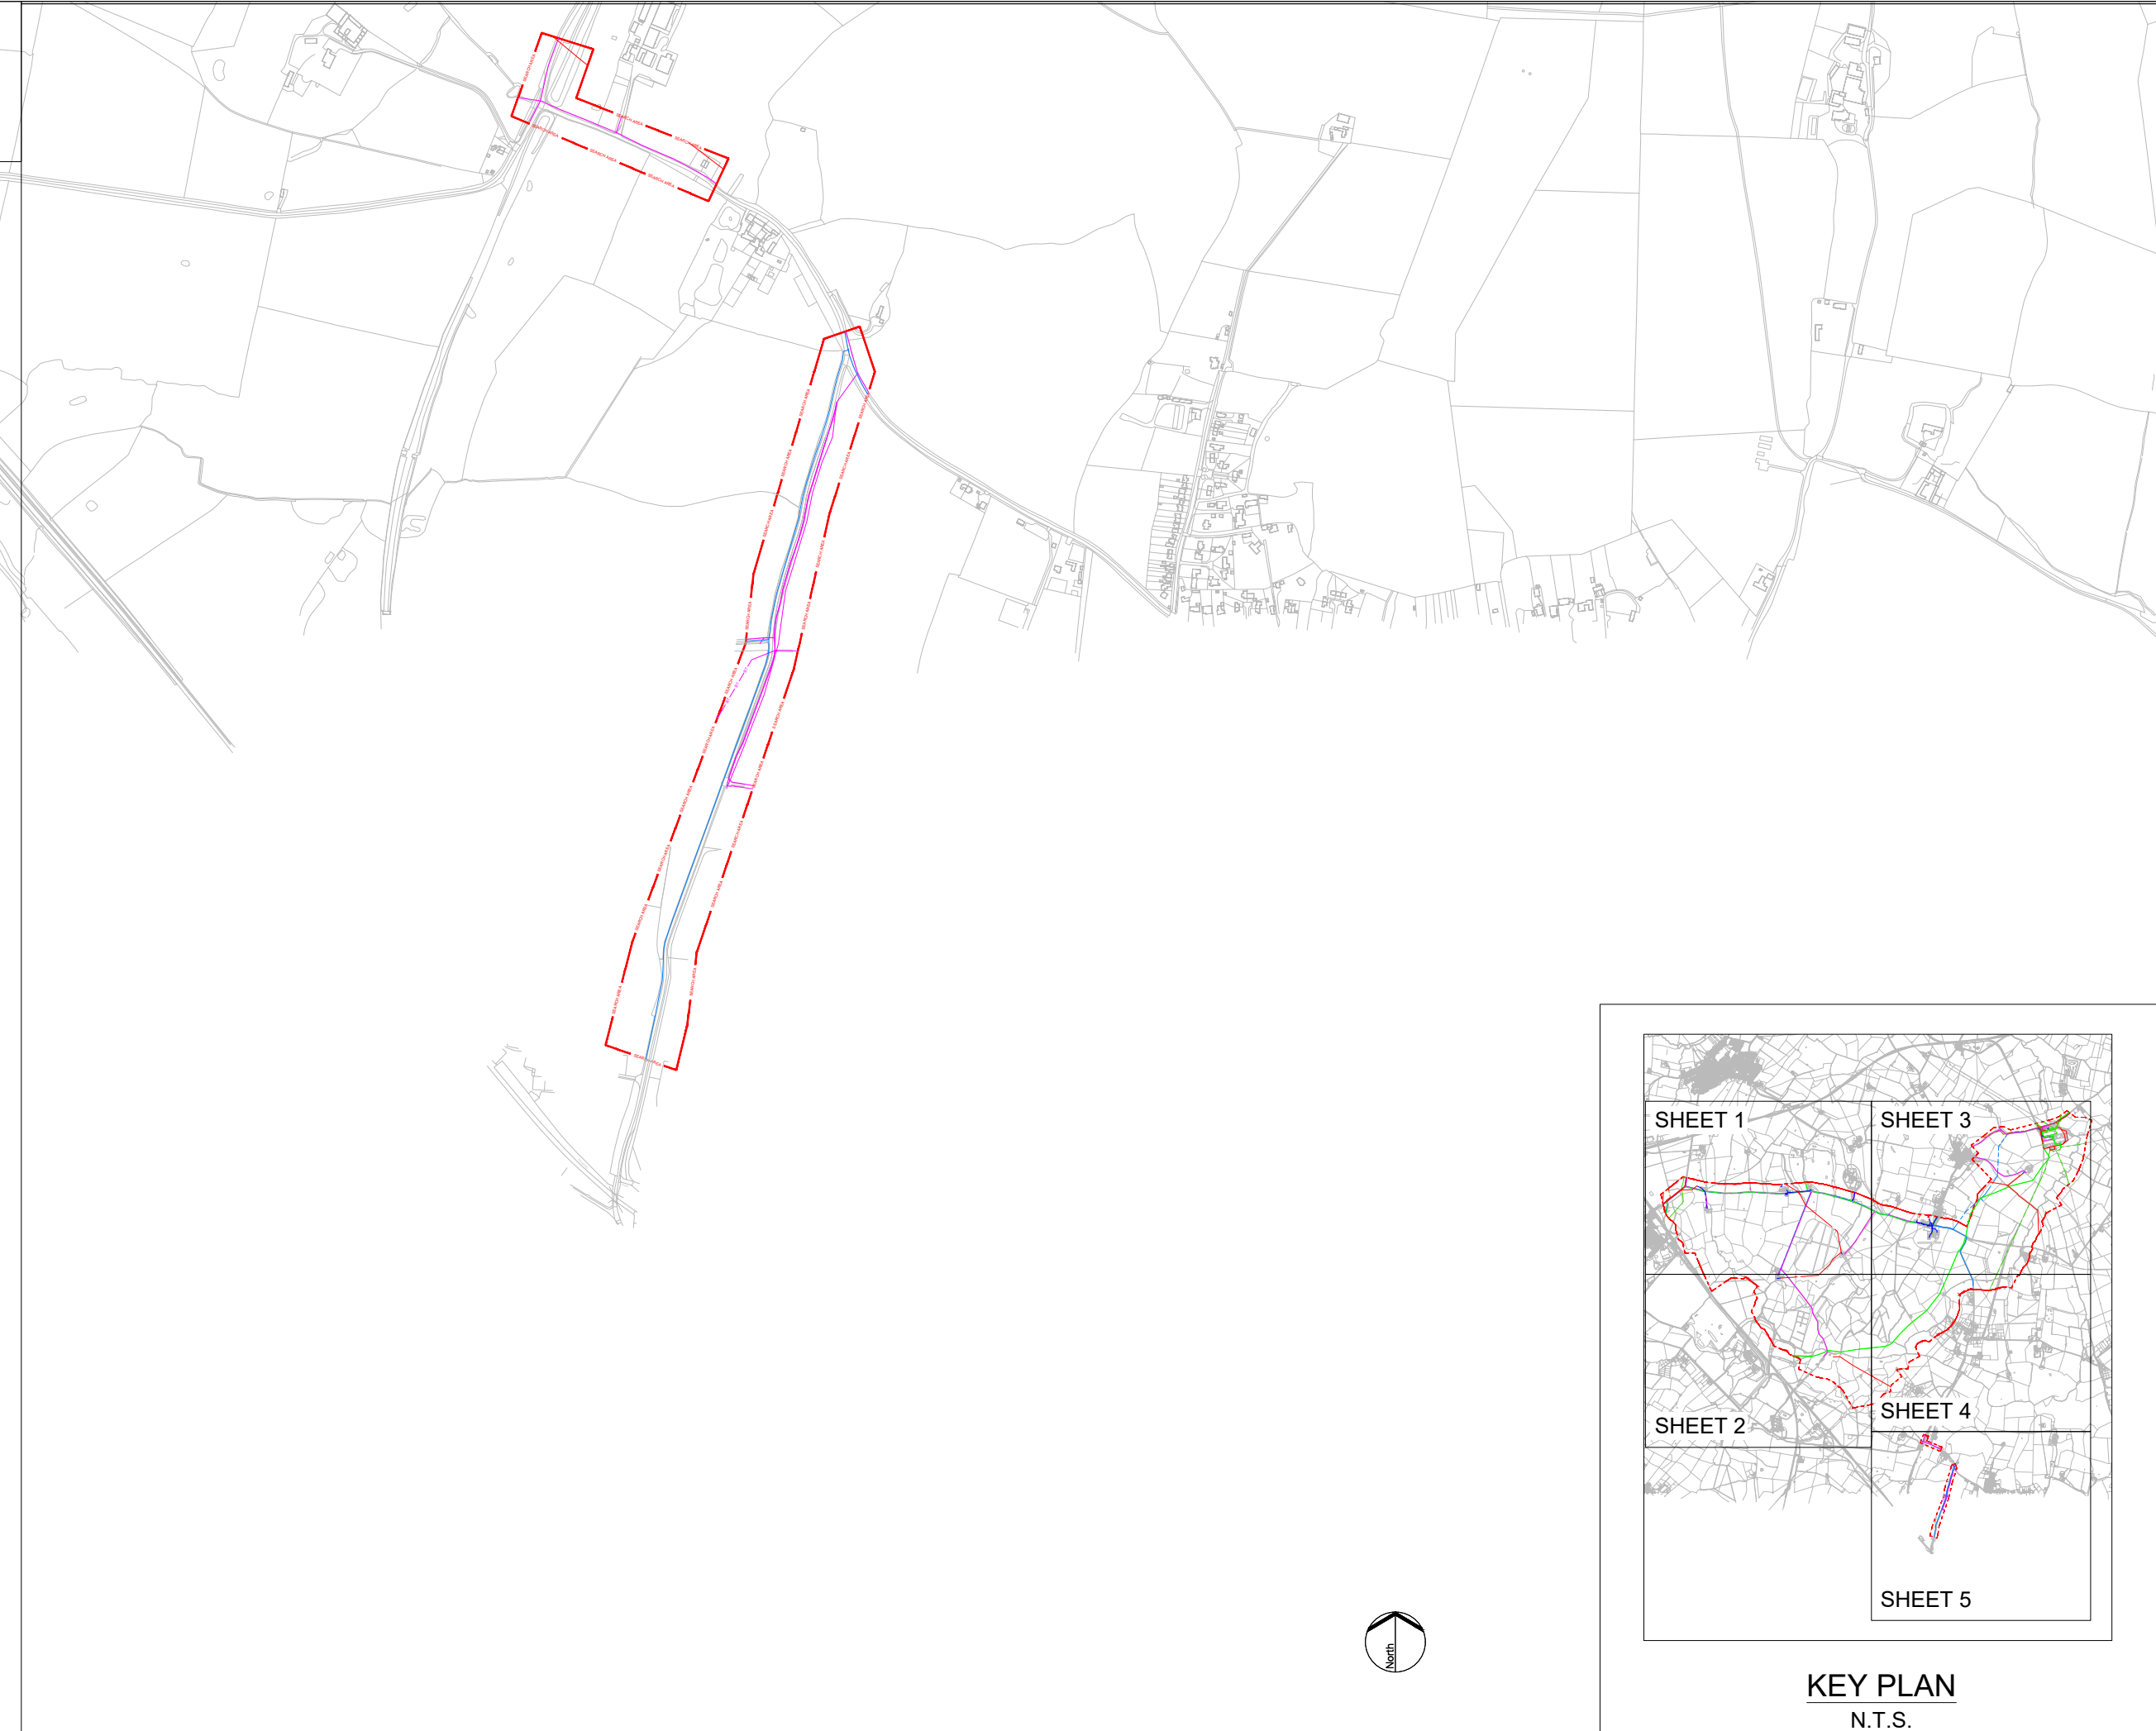

KEY:

ARELION	ARELION	ARELION	G NETWORK
BT	BT	KCOM	KCOM
COLT	COLT	KPN	KPN
CITY FIBRE	CITY FIBRE	LAST MILE	LAST MILE
CSP FIBRE	CSP FIBRE	LU POWERLINK	LU POWERLINK
LV ELEC	LV ELEC	NG FIBRE	NG FIBRE
HV ELEC	HV ELEC	OCU LUMEN	OCU LUMEN
EHV ELEC	EHV ELEC	SEARCH AREA	SEARCH AREA
ES PIPELINES	ES PIPELINES	SEWER SW	SEWER SW
EU NETWORKS	EU NETWORKS	SEWER COM	SEWER COM
EXA	EXA	SKY	SKY
FULCRUM	FULCRUM	TATA	TATA
GAMMA	GAMMA	TFL	TFL
GAS - LP	GAS - LP	VERIZON	VERIZON
GAS - MP	GAS - MP	VIRGIN	VIRGIN
GAS - IP	GAS - IP	VODAFONE	VODAFONE
GAS - HP	GAS - HP	WATER	WATER
GTC ELECTRIC	GTC ELECTRIC	ZAYO	ZAYO
GTC GAS	GTC GAS	GIGACLEAR	GIGACLEAR
GTT	GTT		

LINES MAY INDICATE MULTIPLE CABLES

NOTES:

- THIS DRAWING IS A REPRESENTATIVE "FUSION PLAN" COMPILED FROM PLANS PROVIDED BY ASSET OWNING ORGANISATIONS WHOSE PLANT OR ASSETS COULD BE AFFECTED BY WORKS UNDERTAKEN ON THE SITE DETAILED HEREIN.
- DO NOT SCALE FROM THIS DRAWING
- THE INFORMATION PROVIDED ON THIS MAPPING PLAN IS BASED ON HISTORIC RECORDS PROVIDED BY THE STATUTORY UNDERTAKERS. THE ACTUAL POSITION AND STATUS OF ANY MAINS AND SERVICES MUST BE VERIFIED ON SITE. THIS PLAN IS FOR INFORMATION PURPOSES ONLY.
- THE INFORMATION ON THIS PLAN IS GIVEN WITHOUT OBLIGATION OR WARRANTY. NO LIABILITY OF ANY KIND WHATSOEVER IS ACCEPTED BY CENTARA LTD, OUR AGENTS OR PARTNERS FOR ANY ERRORS OR OMISSIONS.
- SERVICES TO BUILDINGS ARE NOT ALWAYS SHOWN BUT IT MUST BE ASSUMED THAT ANY EXISTING BUILDING IS SERVED WITH "LIVE" SUPPLIES UNTIL PROVEN OTHERWISE. YOU MUST OBTAIN WRITTEN CONFIRMATION FROM THE RELEVANT UTILITY THAT A SUPPLY IS "DEAD".
- CABLES TO STREET LIGHTING, ROAD SIGNS AND ILLUMINATED BOLLARDS ARE NOT ALWAYS SHOWN BUT MUST BE ASSUMED TO EXIST.
- THE LOCATION OF ANY MAINS AND SERVICES MUST BE LOCATED USING EML OR GPR SURVEYS FOLLOWED, IF REQUIRED BY HAND DUG TRIAL HOLES. BEFORE USING ANY MECHANICAL PLANT YOU MUST OBTAIN APPROVAL FROM THE APPROPRIATE UTILITY.
- UNDERGROUND SERVICES MUST BE LOCATED IN ACCORDANCE WITH HSE GUIDANCE NOTE HS (G) 47 AND BSI's PAS 128 2014.

01	Sept 25	DCO SUBMISSION	JR	CC	JH
Rev	Date	Description	Drm	Chk	App

Rosefield Solar Farm




DOCUMENT:
ENVIRONMENTAL STATEMENT
VOLUME 3: FIGURES
REGULATION 5(2)(a)

TITLE:
FIGURE 5.1 - DESK - BASED STUDY OF EXISTING UTILITIES
SHEET 5 OF 5

PINS REFERENCE NUMBER:
EN010158/APP/6.3

SCALE : 1:10,000 @ A3	REV: 01
0m 200m 400m	

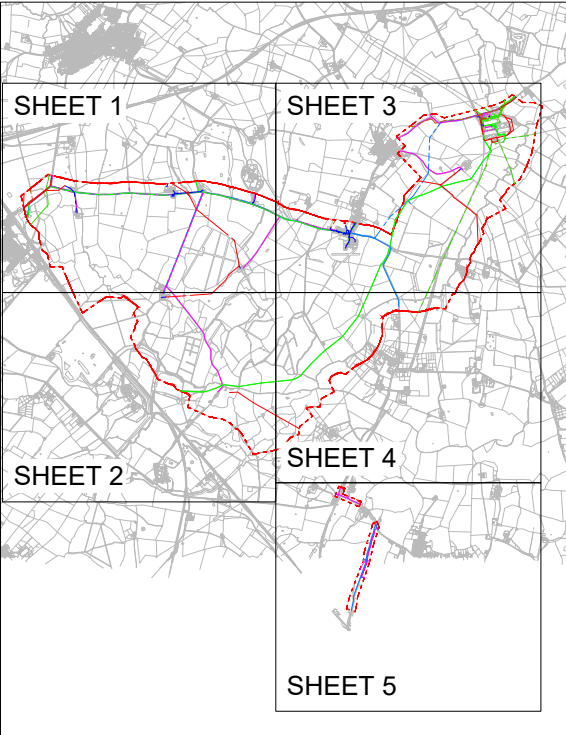

KEY PLAN
N.T.S.

